


LEGEND


- — — — — PROPERTY BOUNDARY
- — — — — ELECTRIC & TELEPHONE SERVICE
- — — — — 4" SCH. 40 PVC SEWER SERVICE
- — — — — 6" SCH. 40 PVC WATER MAIN
- — — — — 1" PEX WATER SERVICE
- — — — — 1" NATURAL GAS SERVICE
- — — — — 4" NATURAL GAS MAIN
- — — — — 4" PERFORATED SCH. 40 PVC LEACH FIELD TRENCH

NOTE: LOCATIONS OF EXISTING UTILITIES SHOWN IS APPROXIMATE. CONTRACTOR SHALL GET ALL UTILITIES SPOTTED AND MAY NEED TO ADJUST THIS DESIGN ACCORDINGLY.

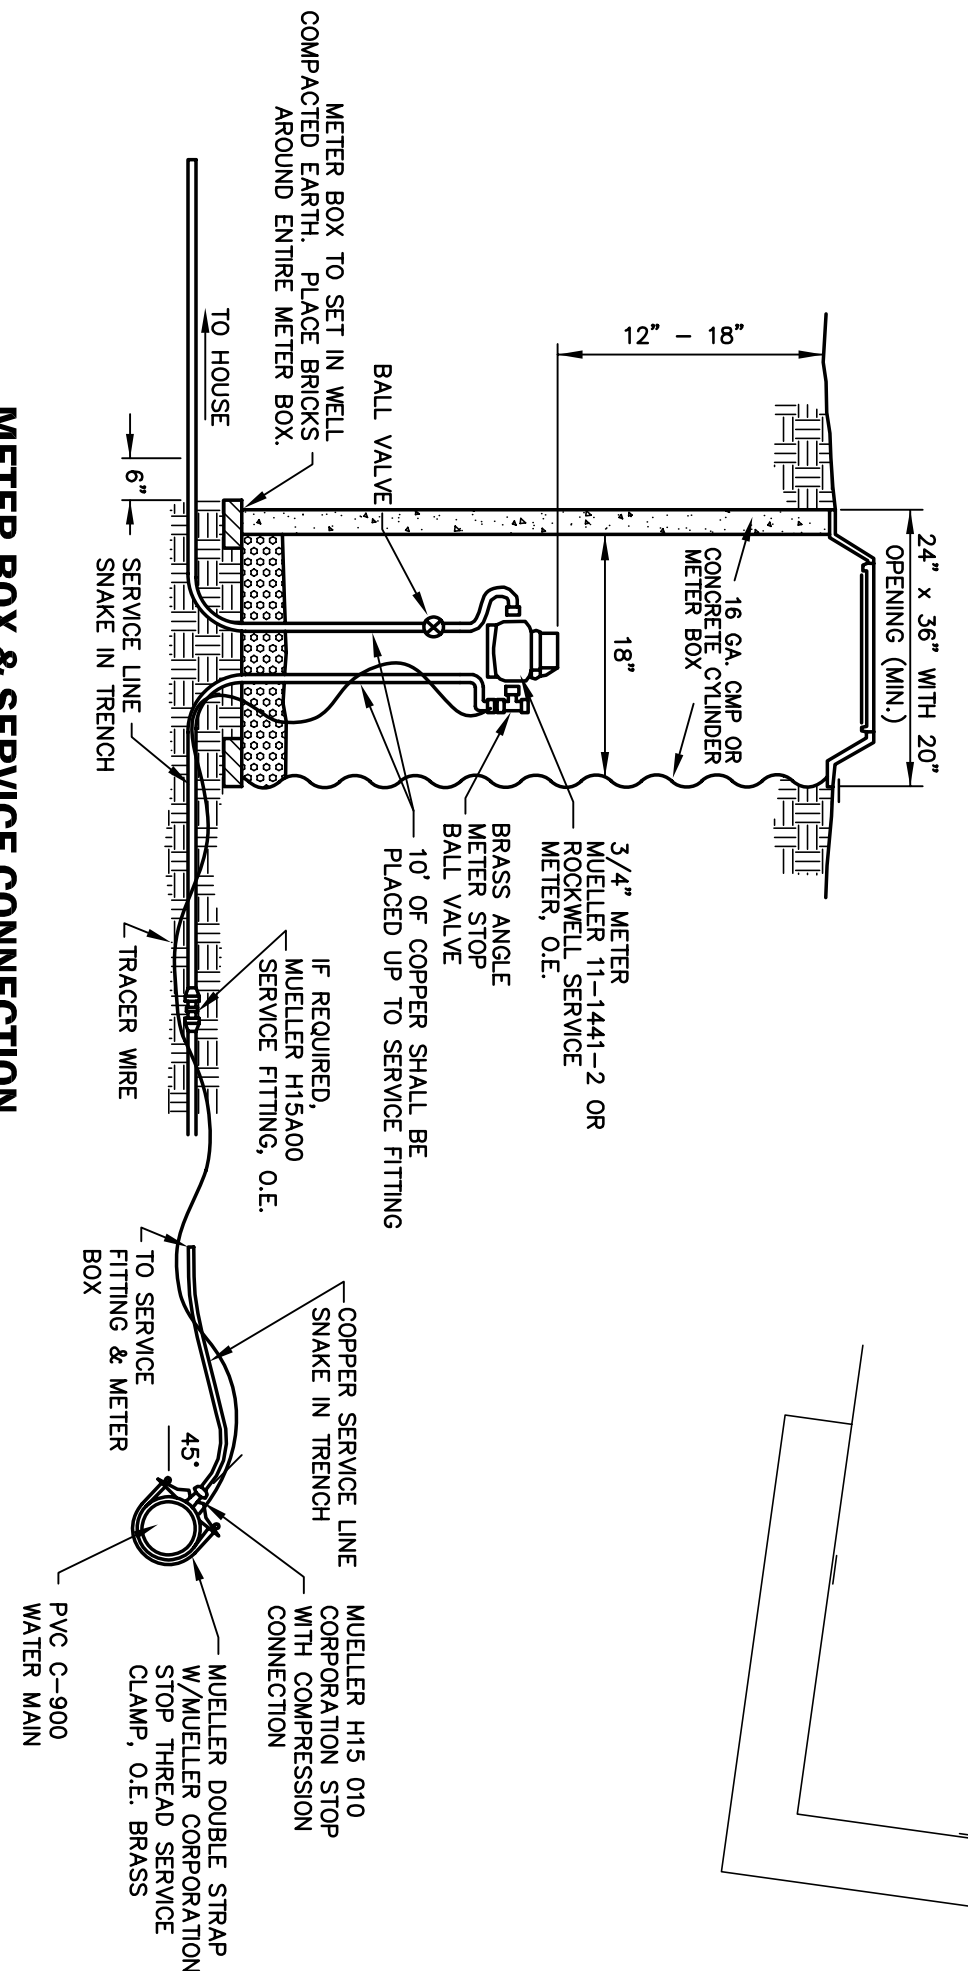


METER BOX & SERVICE CONNECTION
N.T.S.

NOTES: USE TEFLON THREAD LUBRICATION ON ALL CORPORATION STOP THREADS. METER YOKE WILL NOT BE INSTALLED. INSTALL #14 INSULATED COPPER TRACER WIRE FROM MAIN TO METER CAN.

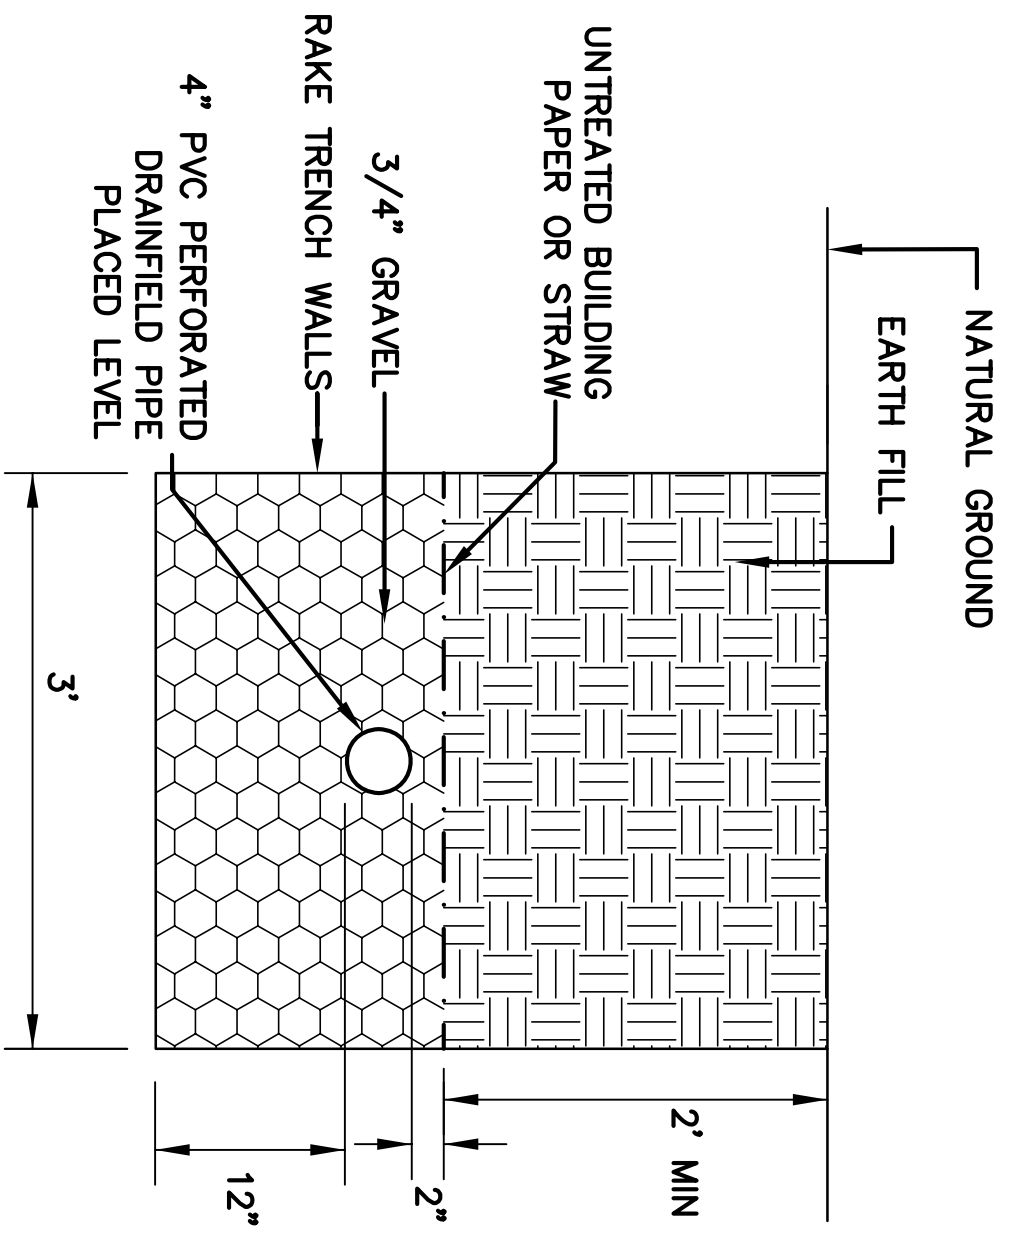

SEPTIC LEACH FIELD DETAIL
N.T.S.

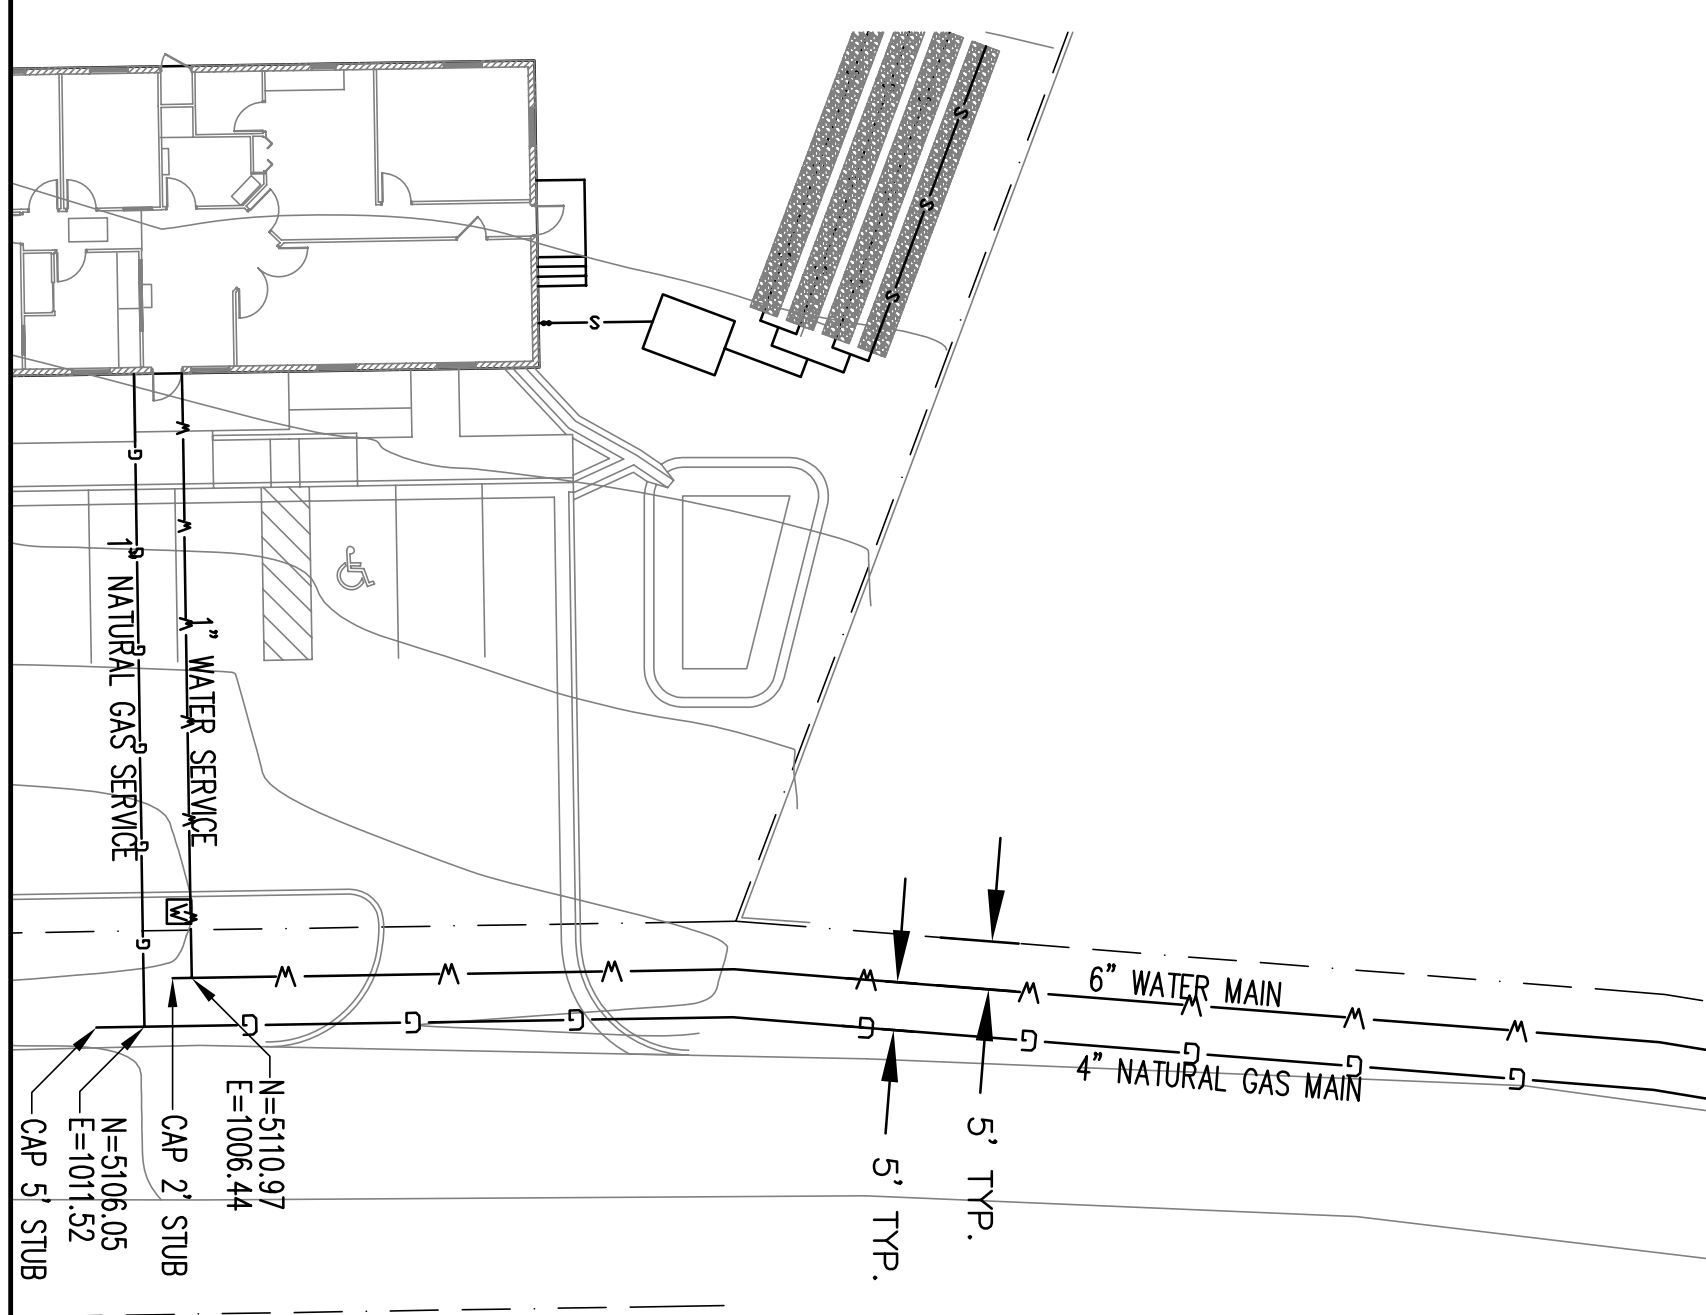

PLAN
SCALE: 1" = 30'

PLAN
SCALE: 1" = 10'

EL VALLE DE LOS RANCHOS WATER & SANITATION DISTRICT			
EL VALLE OFFICE BUILDING			
Taos County, New Mexico			
UTILITY PLAN			
CHECKED: ARA	DATE: JUNE, 2009	ENGR'S. FILE NO.:	SHEET NO.
DRAWN: ABH	SCALE: AS SHOWN	0825	
6			

Abeyta Engineering, Inc.